


CONSTRUCTION DRAWINGS REVIEW

		AS IS:	W/COMMENTS:
REAL ESTATE COORDINATOR:	DATE:	☐	☐
RF ENGINEER:	DATE:	☐	☐
CONSTRUCTION:	DATE:	☐	☐
RESIDENT ENGINEER:	DATE:	☐	☐

LANDLORD APPROVAL

		APPROVED:	AS IS:	W/COMMENTS:
LANDLORD:	DATE:	☐	☐	

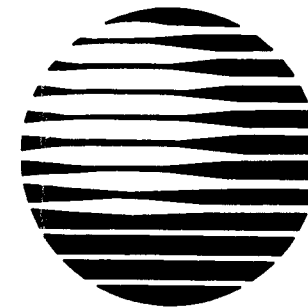

AT&T

AT&T WIRELESS SERVICES, L.L.C.

SITE NUMBER: A-WCHTKSW-223

SITE NAME: MCPHERSON

DRAWING INDEX

REV.

A - WCHTKSW-223-T01 TITLE SHEET

1

TOPOGRAPHIC SURVEY

A - WCHTKSW-223-A01 OVERALL SITE PLAN

1

A - WCHTKSW-223-A02 ENLARGED SITE PLAN

1

A - WCHTKSW-223-A03 GRADING PLAN

1

A - WCHTKSW-223-A04 TOWER ELEVATION AND ANTENNA CONFIGURATION

1

A - WCHTKSW-223-A05 ANTENNA SCHEMATIC AND DETAIL

1

A - WCHTKSW-223-A06 CONSTRUCTION DETAILS

1

A - WCHTKSW-223-A07 FENCE DETAILS

1

A - WCHTKSW-223-A08 GENERAL CONSTRUCTION NOTES

1

A - WCHTKSW-223-E01 ELECTRICAL PLAN

1

A - WCHTKSW-223-E02 ONE-LINE DIAGRAM & DETAILS

1

A - WCHTKSW-223-E03 GROUNDING DETAILS

1

A - WCHTKSW-223-E04 GROUNDING DETAILS

1

A - WCHTKSW-223-E05 ELECTRICAL DETAILS

1


A - WCHTKSW-223-E06 UTILITY RACK DETAIL

1

DIRECTIONS

FROM KANSAS CITY TAKE I-29 NORTH (5 MI.) TO I-435. TAKE I-435 SOUTH (16 MI) TO I-70. TAKE I-70 WEST (159 MI) TO I-135. TAKE I-135 SOUTH (35 MI) TO US 56. TAKE US 56 WEST (1 MI) TO 16th AVE. TAKE 16th AVE. NORTH (2 MI) TO NORTHVIEW AVE. TAKE NORTHVIEW AVE. EAST (1 MI) TO DRIVE ON NORTH SIDE OF ROAD. TAKE DRIVE NORTH TO SITE.

VICINITY MAP

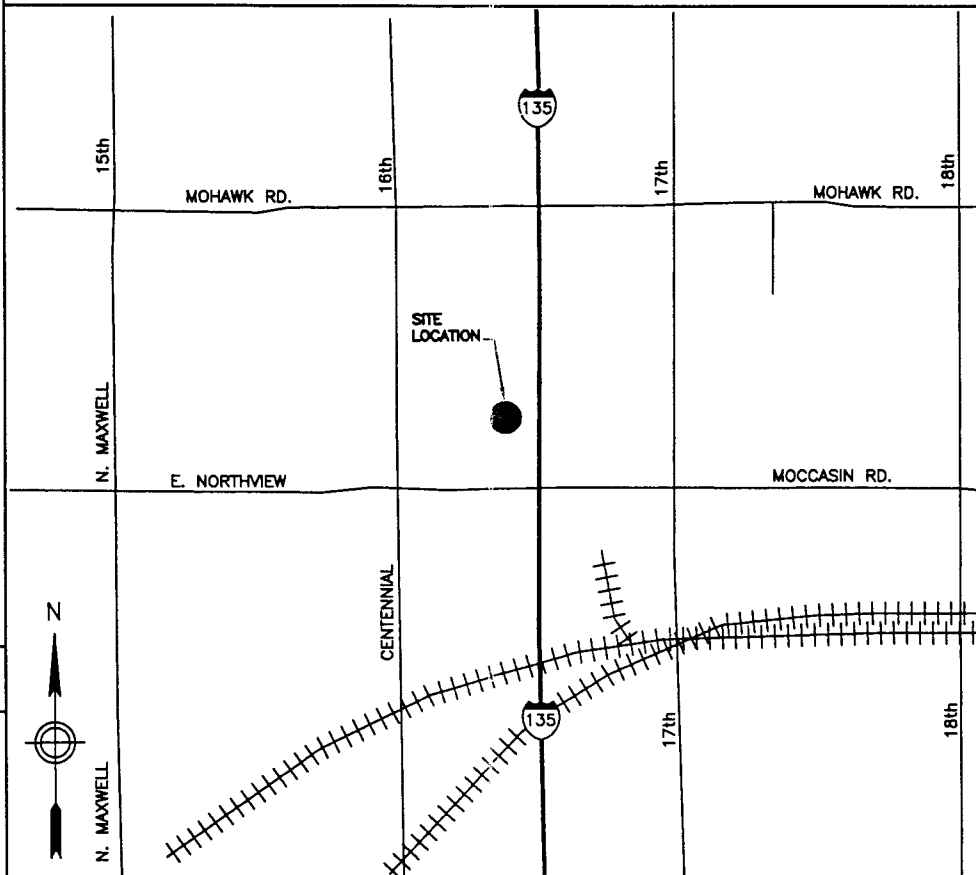

PROJECT INFORMATION

SCOPE OF WORK:	AN UNMANNED TELECOMMUNICATIONS FACILITY
SITE ADDRESS:	E. NORTHVIEW RD. MCPHERSON, KANSAS 67460
PROPERTY OWNER:	PAULA LARSON 1548 16th AVE. MCPHERSON, KANSAS 67460
CONTACT PERSON:	PAULA LARSON PHONE: (620) 241-5621
APPLICANT:	AT&T WIRELESS SERVICES, INC. 10920 AMBASSADOR DRIVE, SUITE 200 KANSAS CITY MISSOURI 64153 PHONE: 816-584-4111 FAX: 816-584-4199
LATITUDE:	38° 23' 41.87" N (NAD 83)
LONGITUDE:	97° 37' 23.09" W (NAD 83)
ELEVATION:	1512' AMSL
JURISDICTION:	MCPHERSON COUNTY
CURRENT USE:	TELECOMMUNICATIONS FACILITY
PROPOSED USE:	TELECOMMUNICATIONS FACILITY

SURVEYOR'S FLOOD NOTE

According to my interpretations of Community Panel No. 200217 0010 D of the Flood Insurance Rate Map for McPherson County, Kansas, dated 03-16-1983, the subject property is in Flood Zone "C", i.e. "areas of minimal flooding".

SITE QUALIFICATION PARTICIPANTS

	NAME	COMPANY	NUMBER
A/E	HOSSEIN NOVIN	SSC	913-438-7700
SAC	MIKE FRASER	SSC	913-438-7700
RF	JARRET GUILL	ATTWS	469-229-7227
CONTRACTOR	MIKE McCORMICK	BECHTEL	713-447-0731
SUBCONTRACTOR	PAULA LARSON	CONSTRUCTION CENTRAL	
LANDLORD	PAULA LARSON		620-241-5621

MISCELLANEOUS NOTES

DETAIL NUMBERS MARKED WITH (MOD) OR MODIFIED INDICATES BECHTEL DETAIL MODIFIED TO SITE SPECIFIC CONDITIONS.

CORRESPONDING BECHTEL SITE NO: 932-350-012

KDOT TYPE AB-3 - REFER TO KANSAS DEPT. OF TRANSPORTATION STANDARD SPECS. FOR STATE ROAD AND BRIDGE CONSTRUCTION --SUBSECTION 1105 - AGGREGATES FOR AGGREGATE BASE CONSTRUCTION.



SELECTIVE SITE CONSULTANTS, INC.
A Site Acquisition, Engineering, and Construction Quality Assurance Company

8500 W. 110th St., Suite 300 Phone: 913-438-7700
Overland Park, Kansas 66210 Fax: 913-438-7777

MCPHERSON
SITE NO. A-WCHTKSW-223



E. NORTHVIEW RD.
MCPHERSON, KANSAS 67460



AT&T

AT&T WIRELESS SERVICES, INC.
10920 AMBASSADOR DRIVE, SUITE 200
KANSAS CITY, MISSOURI 64153

NO.	DATE	REVISIONS	BY	CHK	APP'D
1	5/29/03	ISSUED FOR CONSTRUCTION	EWS	HAN	HAN
0	03/21/03	ISSUED FOR ZONING APPROVAL	JRH	HAN	HAN
A	03/10/03	ISSUED FOR ZONING	JRH	HAN	HAN
NO.	DATE	REVISIONS	BY	CHK	APP'D
SCALE: AS SHOWN			DESIGNED: JRH		
			DRAWN: JRH		

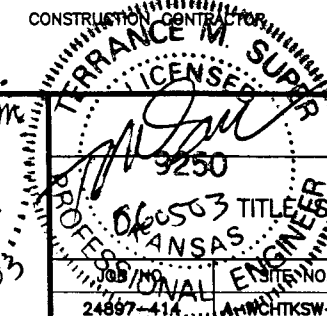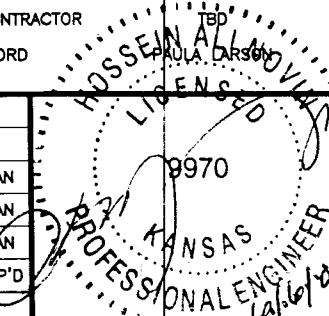

060503 TITLE SHEET
KANSAS

24897-414
A-WCHTKSW-223

DRAWING NO. T01
REV 1